


दुर्गावती (DGO)

MACLS, B" CLASS, STD-III
DOC:-24.06.15

SSI



OF STN. BLD.
KM.629.20
FROM HWH

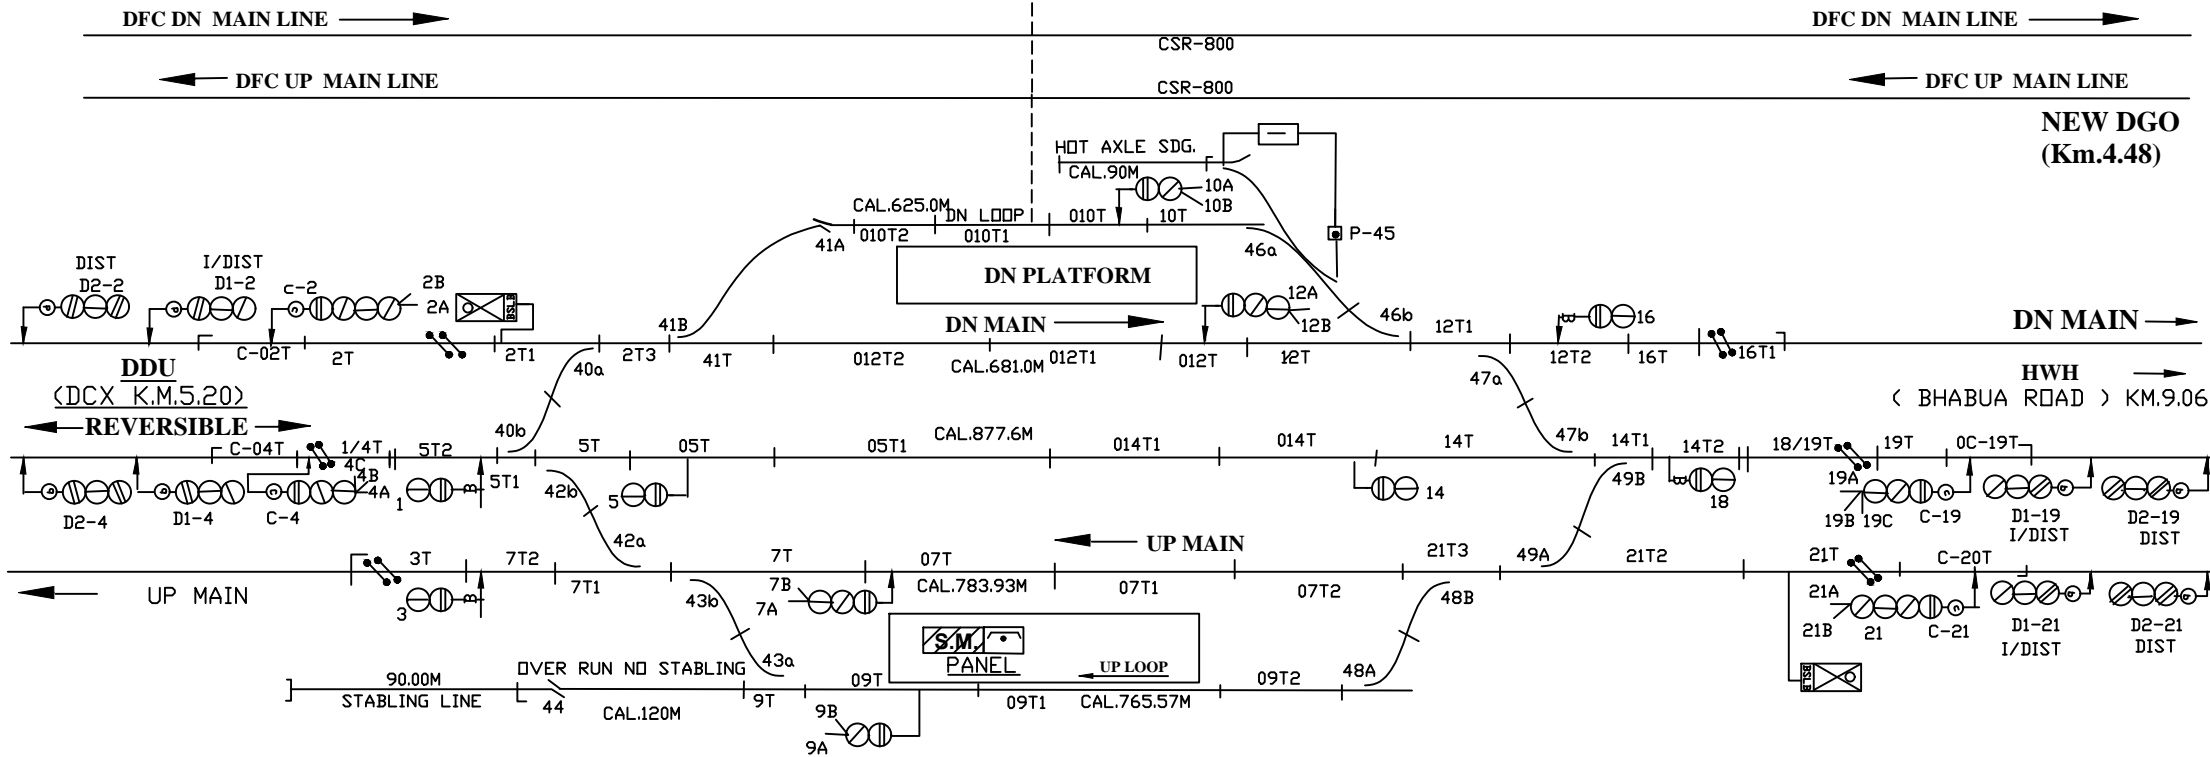

TO SUIT SIP. NO. ECR/SIP/DDU/007/2014

E C R			ELECTRONIC INTERLOCKING	DURGAUTI DDU. DIV.	DRG. No. SG/DDU/ SK/2020 SH. No. 8
	SSE/DRG	DSTE/DDU			